


REVISIONS	BY
1/27/06	GW

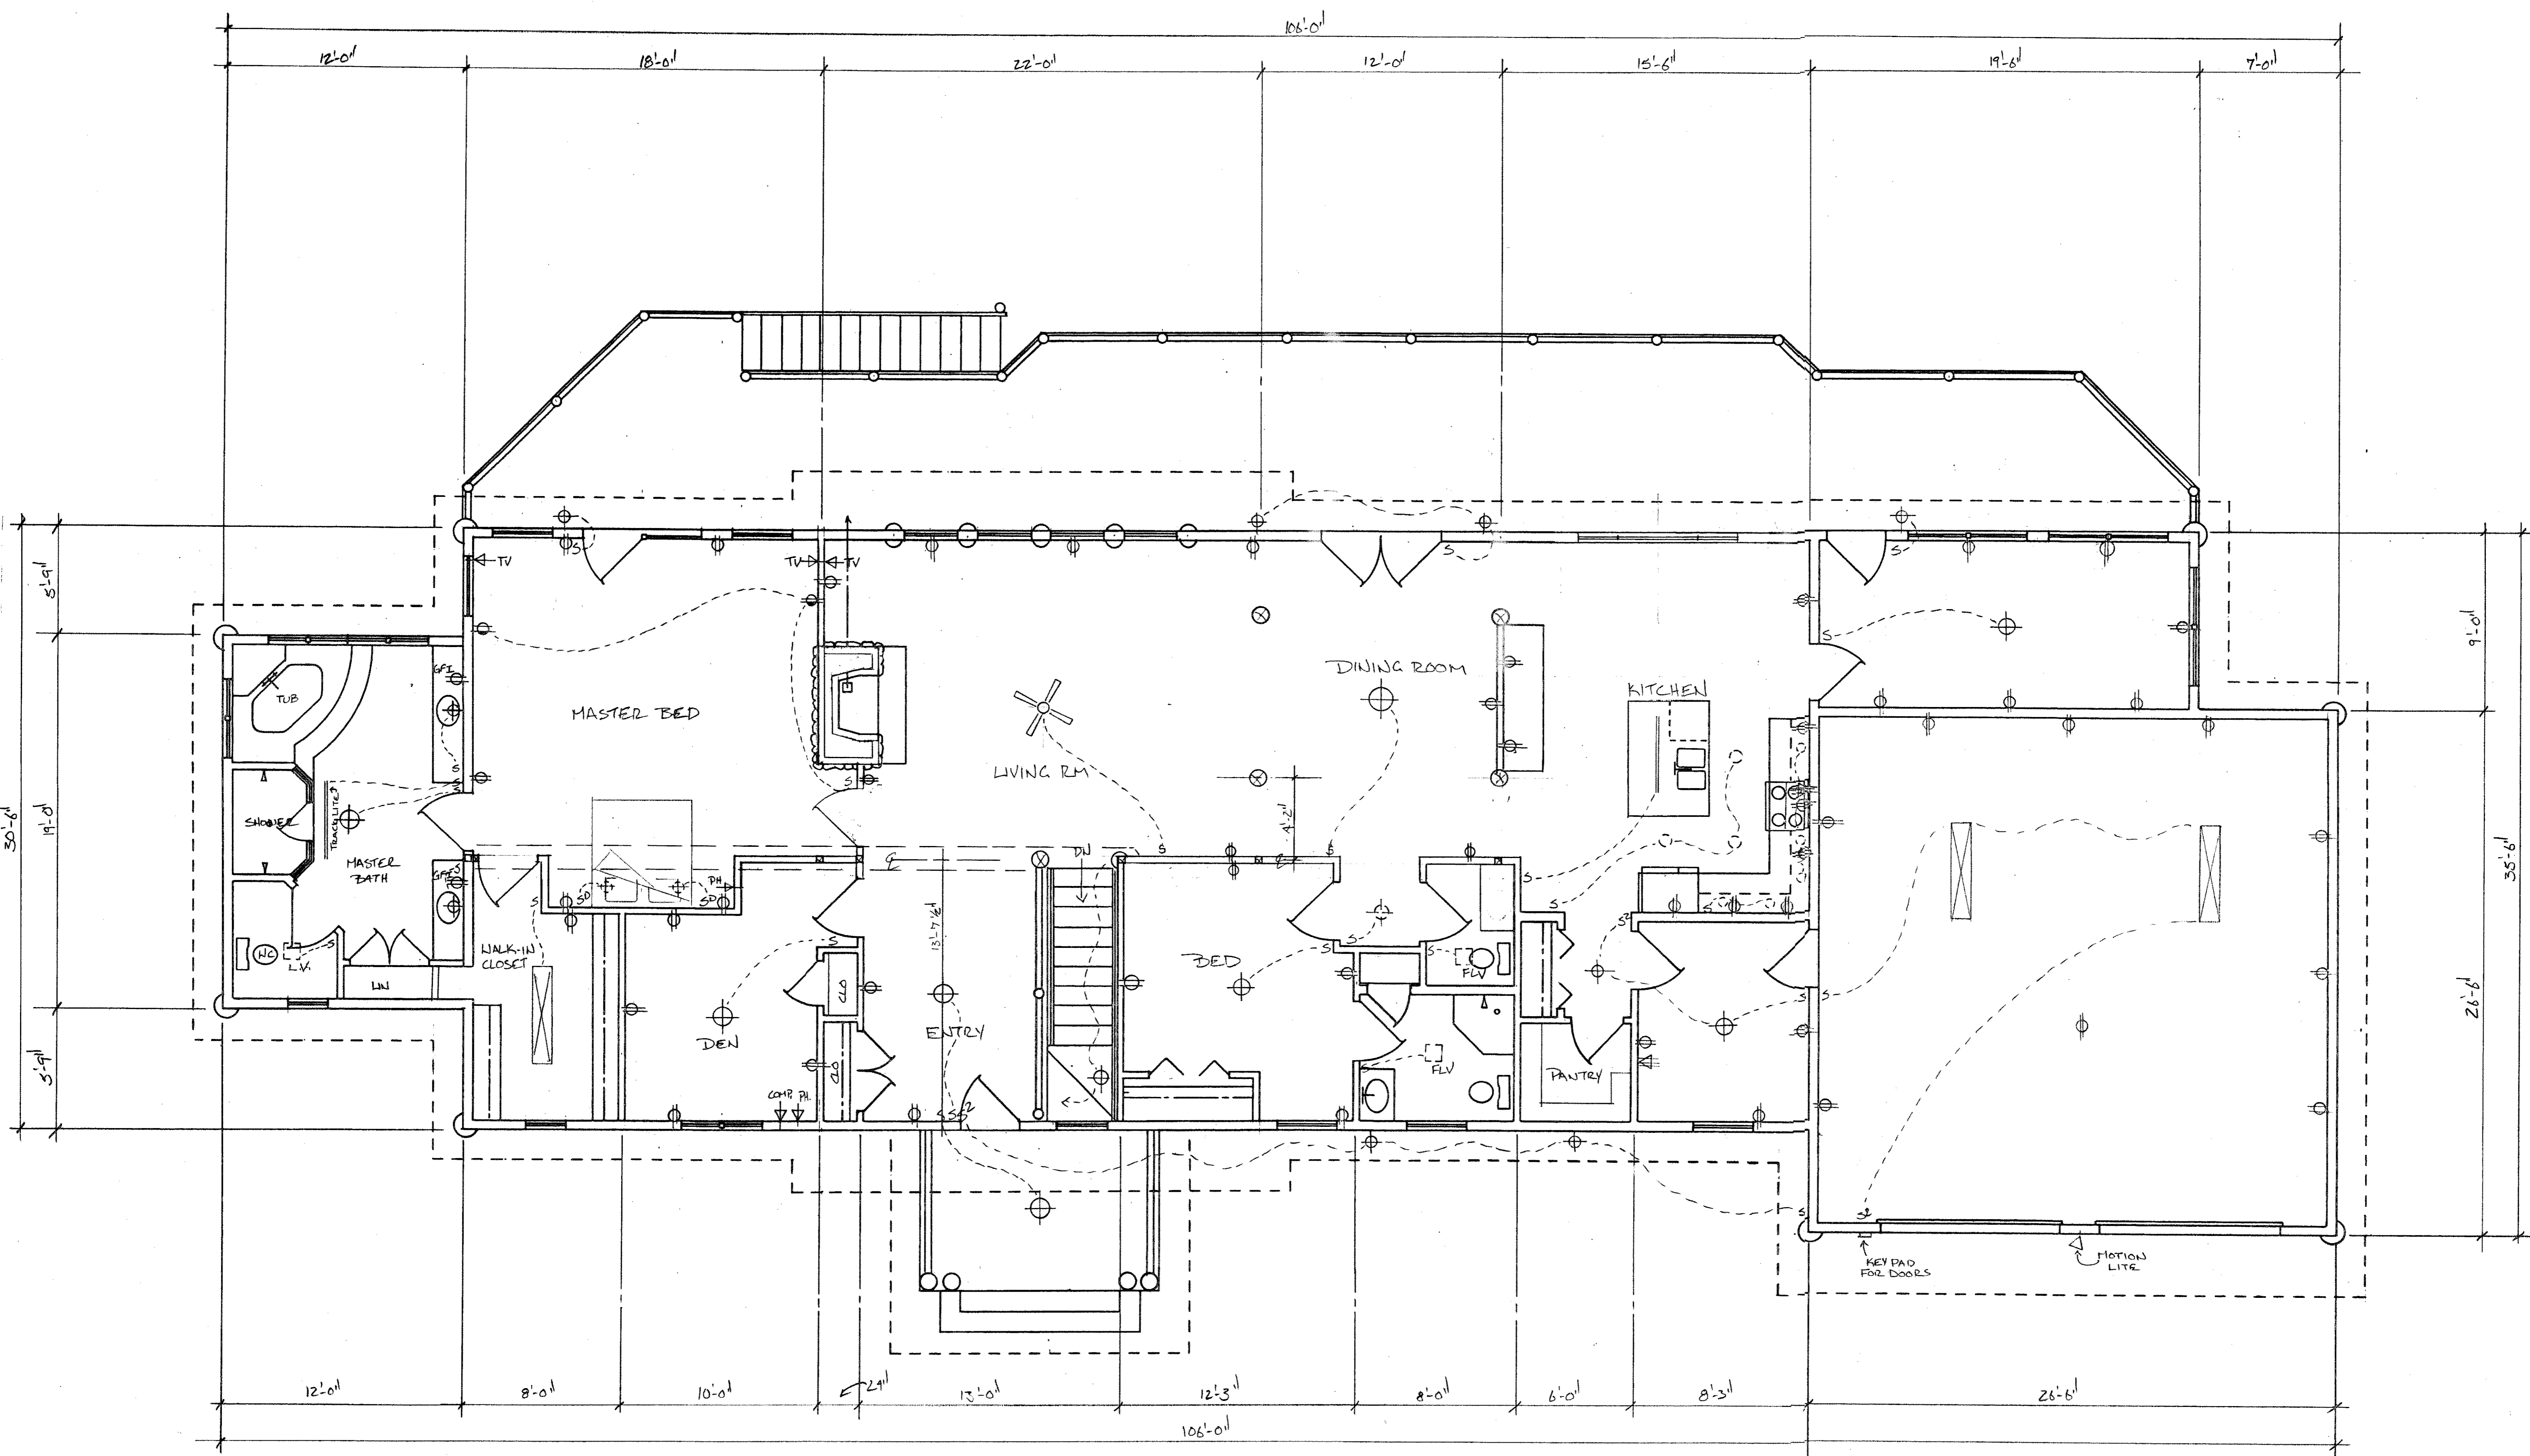

# ELECTRICAL PLAN MAIN FLOOR

SCALE 1/4" = 1'-0"

MAIN ELECTRICAL PLAN  
SCALE 1/4" = 1'-0"

JIM & MAUREEN LOVE RESIDENCE  
SEELEY LAKE MONTANA 59868

Date	
Scale	
Drawn	
Job	
Sheet	12
Of 13 Sheets	